


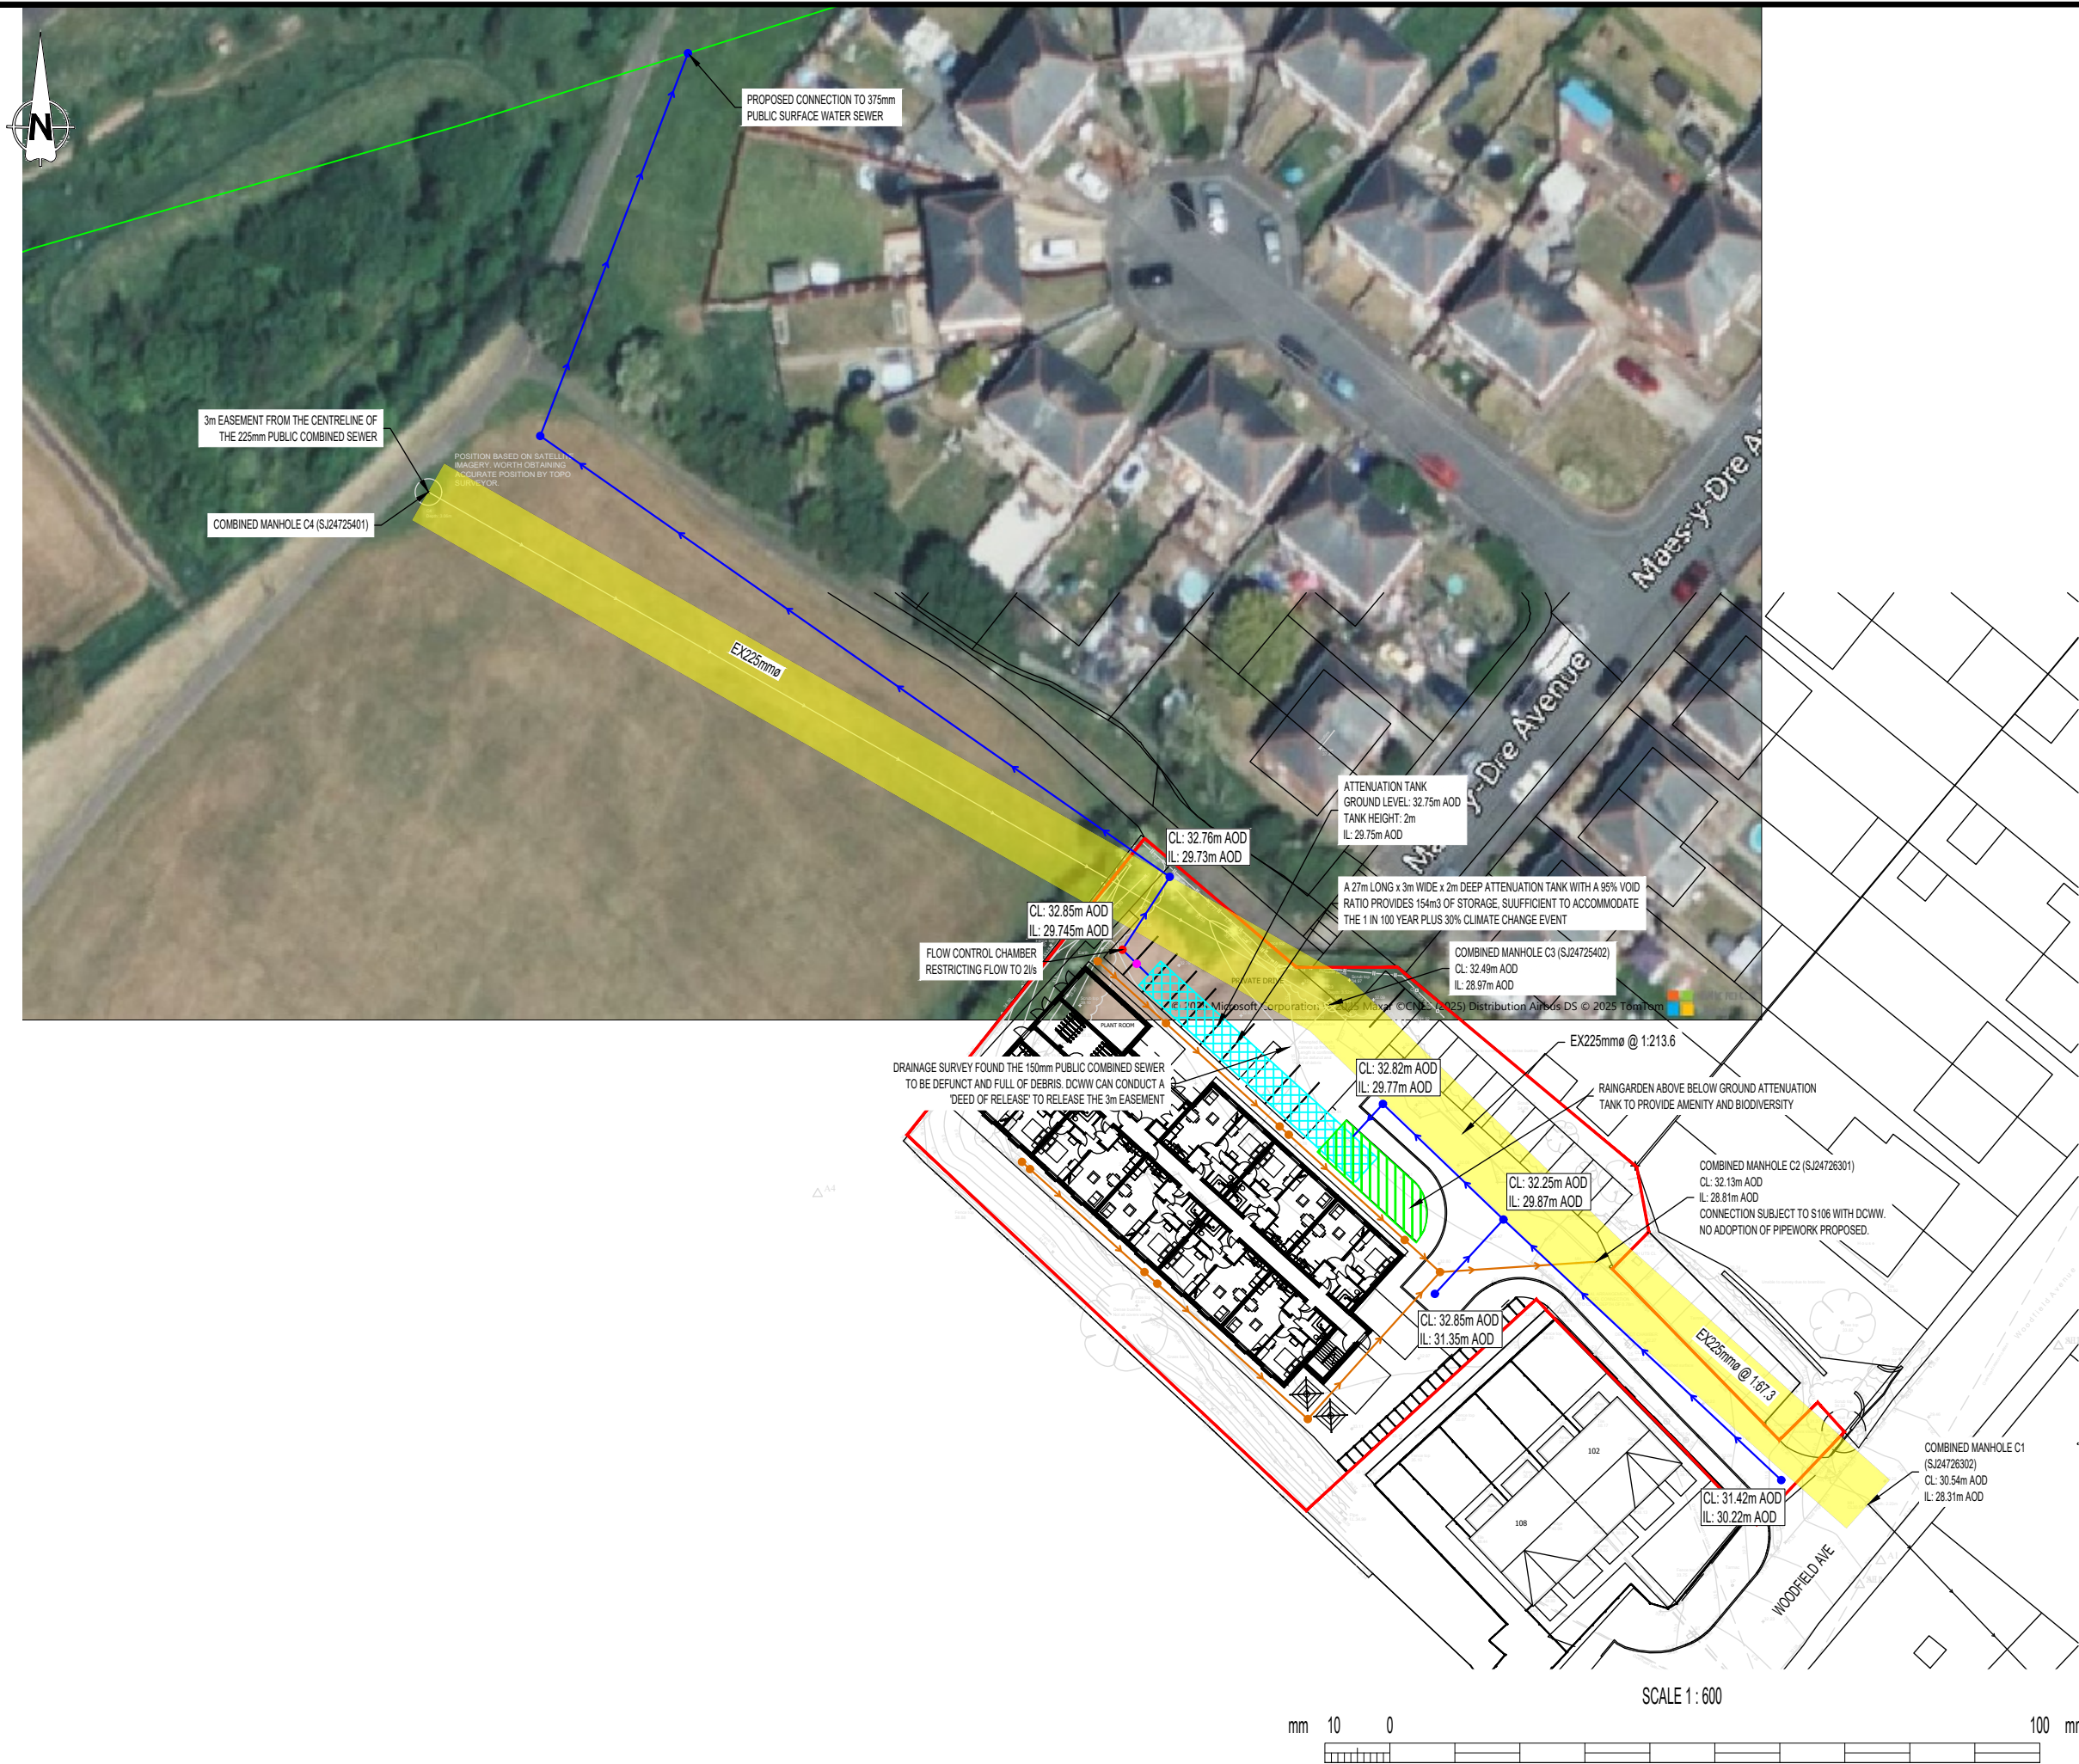

- NOTES**
- THIS SKETCH HAS NOT BEEN SUBJECT TO FORMAL CHECKS OR APPROVALS. ITS VALIDITY AND USE MUST THEREFORE BE LIMITED TO DISCUSSION AND INFORMATION PURPOSES ONLY.
 - ALL DIMENSIONS IN MILLIMETRES AND ALL LEVELS IN METRES ABOVE ORDNANCE DATUM UNLESS SHOWN OTHERWISE.
 - THIS DRAWING IS AN AMMENDMENT OF THE 'WAF-HOH-XX-XX-DR-A-1201-Detailed Site Plan' BY 'Hughes O'Hanlon Architects'. THIS DRAWING PROVIDES A CONCEPT ONLY AND IS NOT INTENDED FOR DETAILED DESIGN.

- KEY**
- SITE BOUNDARY
 - PROPOSED ATTENUATION TANK
 - PROPOSED RAIN GARDEN
 - DCWW PUBLIC COMBINED SEWER
 - DCWW PUBLIC SURFACE WATER SEWER
 - PROPOSED SURFACE WATER SEWER
 - PROPOSED SURFACE WATER INSPECTION CHAMBER
 - PROPOSED FLOW CONTROL CHAMBER
 - PROPOSED SDS AQUA-SWIRL
 - PROPOSED PRIVATE NON-ADOPTED FOUL SEWER AND CHAMBER

REV02	27/04/2026	TURNING HEAD EXTENT ALTERED	LG	AC	NJ
REV01	06/10/2025	FIRST ISSUE	LG	AR	NJ
REV	DATE	DESCRIPTION	ORIG	CHK	APP

CLIENT

ENFYS DEVELOPMENTS Ltd

PRINCIPAL DESIGNER

Waterco

Waterco Ltd., Eden Court,
Lon Parow Business Park, Ruthin LL15 1NJ

tel (+44) 1824 702220
www.waterco.co.uk

SCHEME

FORMER WORKING MEN'S CLUB, FLINT

TITLE

CONCEPT DRAINAGE SKETCH

ORIGINATOR	CHECKER	APPROVER
LG	AR	NJ

STATUS

FOR INFORMATION

SCALE / SHEET SIZE	REV
1:600 / A3	REV02

DRAWING NO.

16445_CONCEPT_DRAINAGE_SKETCH